


REVISIONS			
ZONE LTR	DESCRIPTION	DATE	APPROVED
	ISSUED FOR APPROVAL		

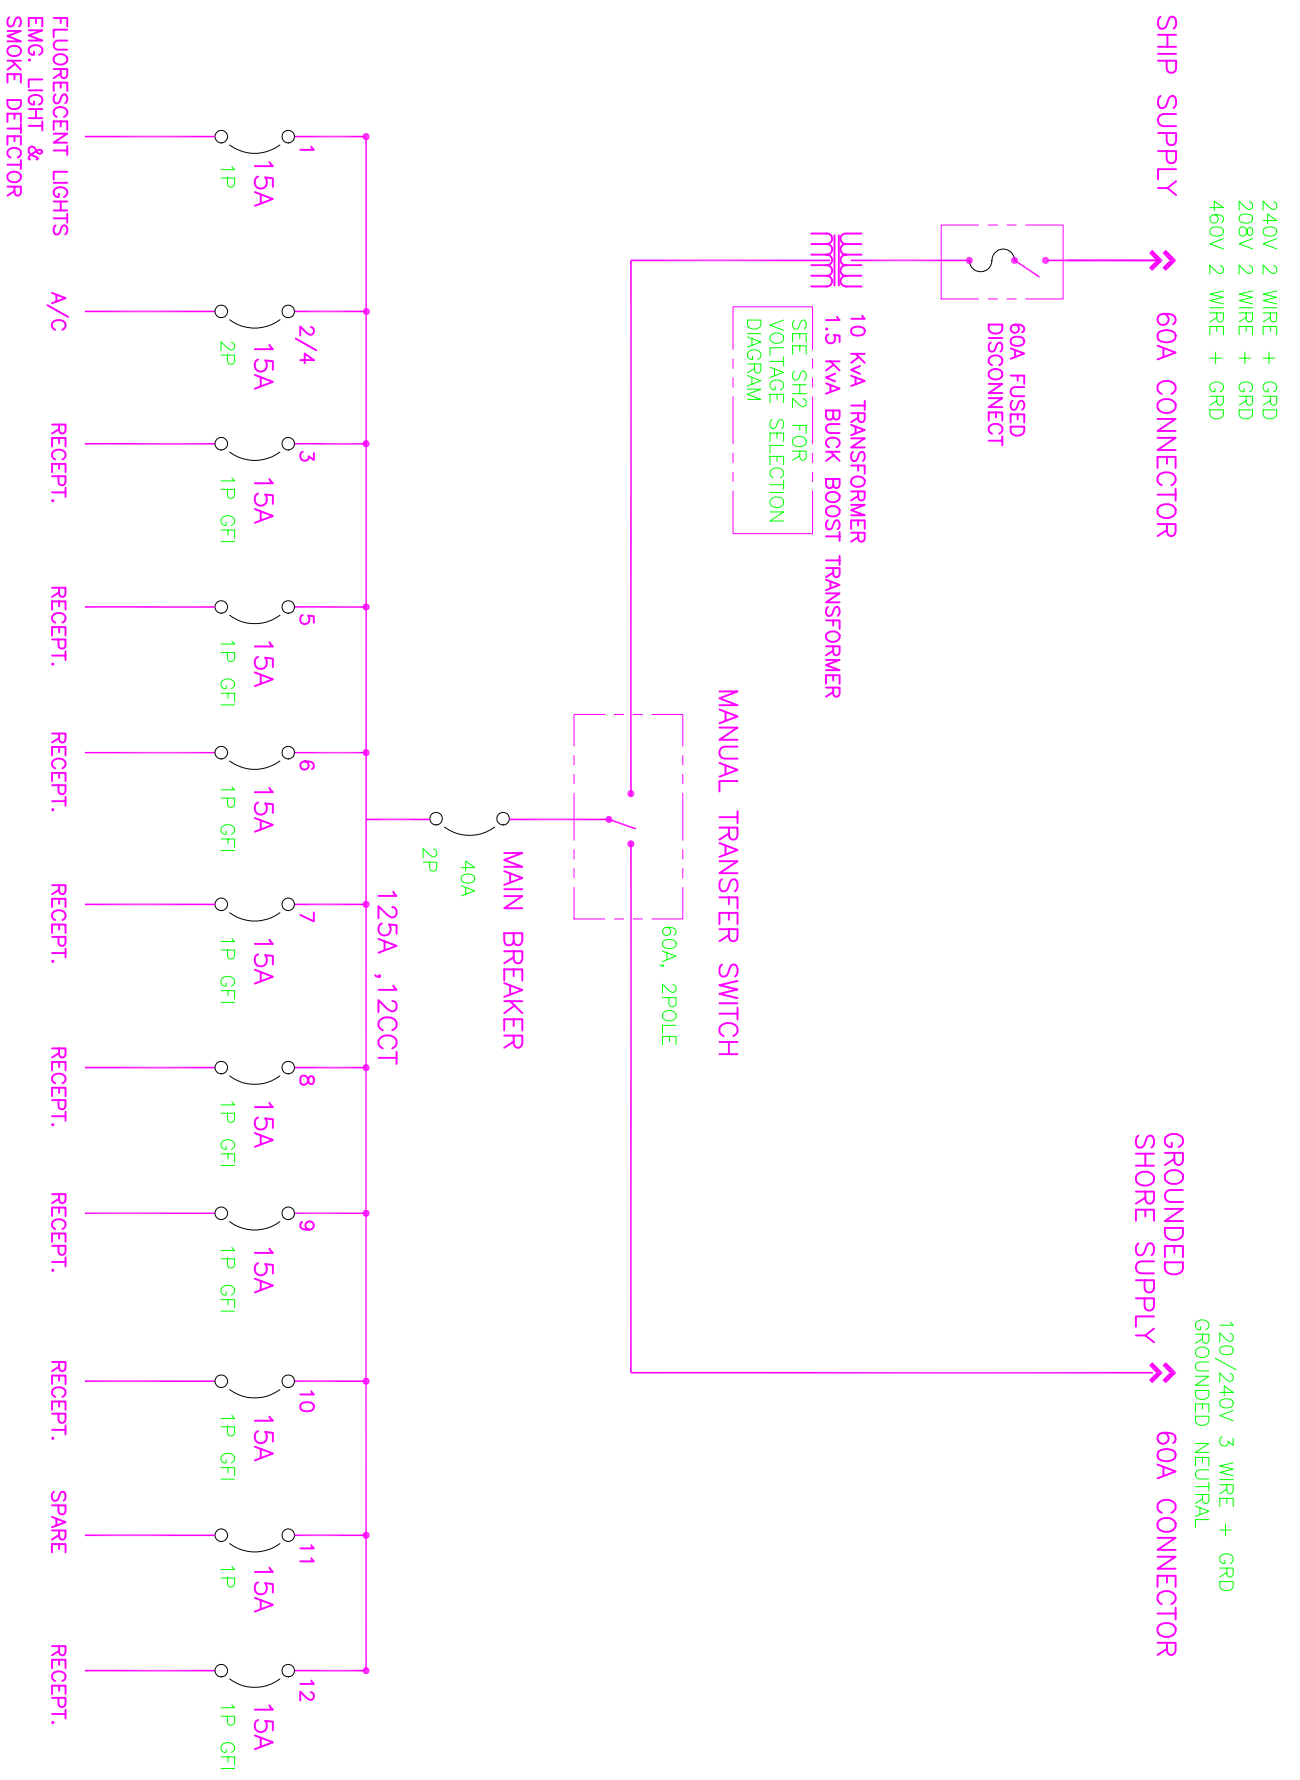

THIS IS A PROPRIETARY DESIGN OF SONIC BARRIER SOUND PRODUCTS LTD. MANUFACTURE, REPRODUCTION OR USE OF ANY ASSEMBLY, SUBASSEMBLY OR PART IS NOT PERMISSIBLE EXCEPT IF EXPRESSLY PRIOR AUTHORIZED IN WRITING BY SONIC BARRIER SOUND PRODUCTS LTD.

UNLESS OTHERWISE SPECIFIED DIMENSIONS ARE IN INCHES TOLERANCES	
CONTRACT No.	592.3.01
FRAC TIONAL ± .01"	
DECIMAL ± .031"	
ANGULAR ± 1°	
DO NOT SCALE DRAWING	
DRAWN	DAVE D.
CHECK	DAVE G.
DESIGN	DAVE G.
DESIGN ACTIVITY	21.FEB.03
CUSTOMER	
U OF HAWAII	

**ELECTRICAL SCHEMATIC ONE LINE DIAGRAM**

TITLE	SIZE	FSCM NO	DWG No	REV.
			592301-04	

7973 PROGRESS WAY  
 DELTA B.C. V4G 1A3  
 PH- 604 946-8100  
 FX- 604 946-6967

SCALE NTS      RELEASE DATE      SHEET 1 OF 3